




DAVID BRACK ENGINEERING, LLC
 10000 WOODBURN ROAD
 GAITHERSBURG, MD 20882
 TEL: 301.717.1393
 jbrack@verizon.net

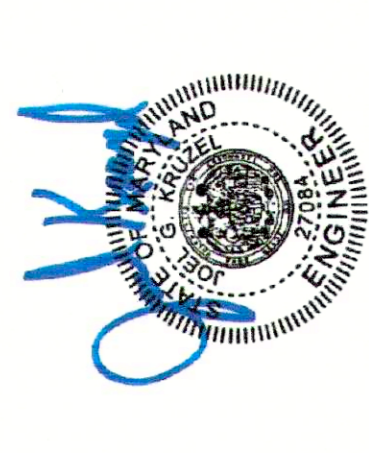


PROFESSIONAL CERTIFICATION:
 I, DAVID BRACK, ENGINEER, LICENSE NO. 22284, AM
 LICENSED PROFESSIONAL ENGINEER UNDER THE
 LAWS OF THE STATE OF MARYLAND.

LICENSE NO. 22284
 EXPIRATION DATE: 01/31/22


**DUPLEX PUMP STATION
 MODIFICATIONS**
 BAY AVENUE AND FIFTH STREET
 NORTH BEACH, MARYLAND

NO.	DATE	DESCRIPTION

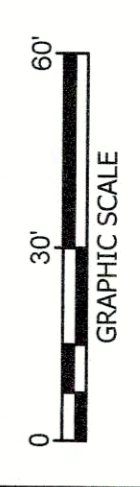

DATE: DEC 16, 2021
 CAA PROJECT NO.:
 DRAWN BY: JJK
 CHECKED BY: CNT
 SHEET TITLE:

**RISER
 DIAGRAMS
 AND DETAILS**

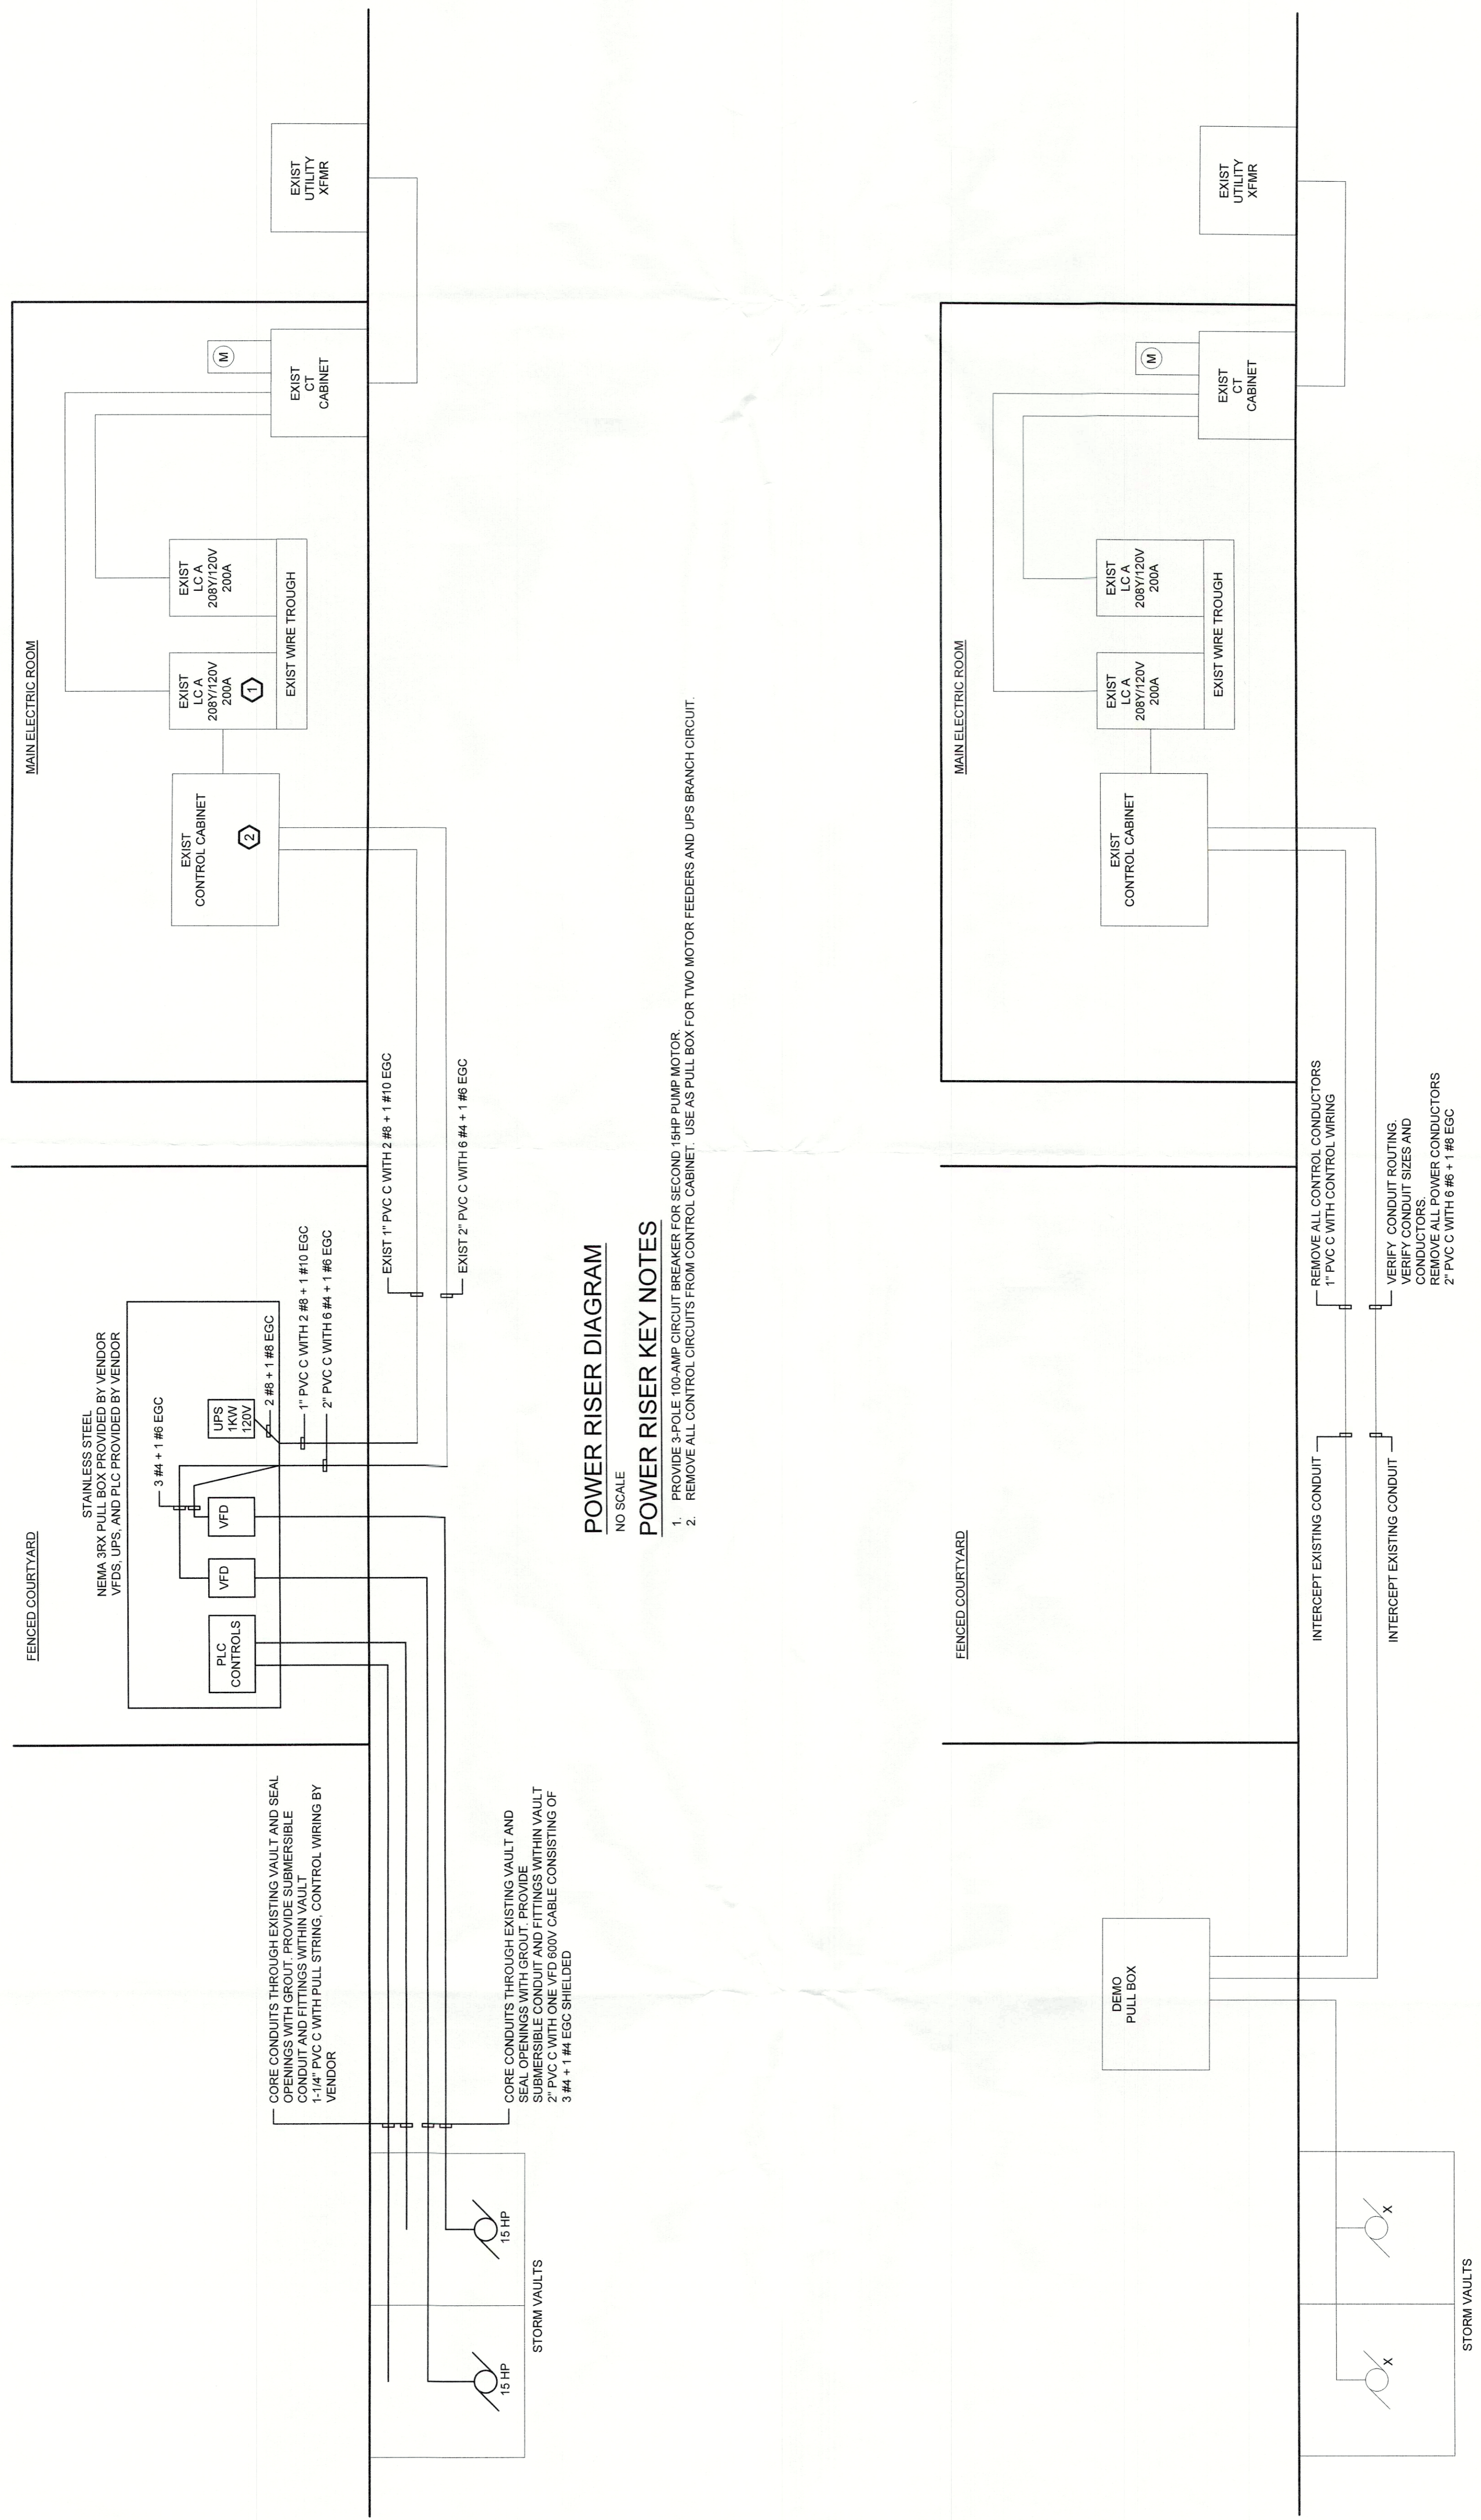

POWER RISER DIAGRAM
 NO SCALE

POWER RISER KEY NOTES

1. PROVIDE 3-POLE 100-AMP CIRCUIT BREAKER FOR SECOND 15HP PUMP MOTOR
2. REMOVE ALL CONTROL CIRCUITS FROM CONTROL CABINET. USE AS PULL BOX FOR TWO MOTOR FEEDERS AND UPS BRANCH CIRCUIT.

DEMOLITION POWER RISER DIAGRAM
 NO SCALE

TOWN OF NORTH BEACH
 PUBLIC WORKS ENGINEER
 APPROVED: [Signature]
 DATE: 2/15/2022